

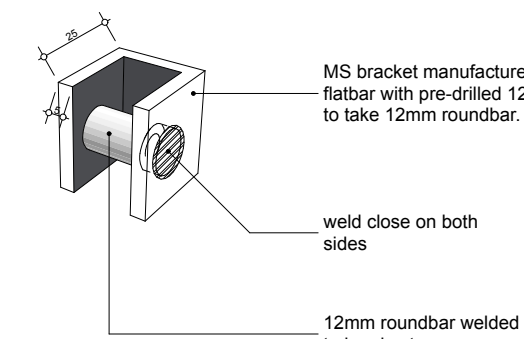
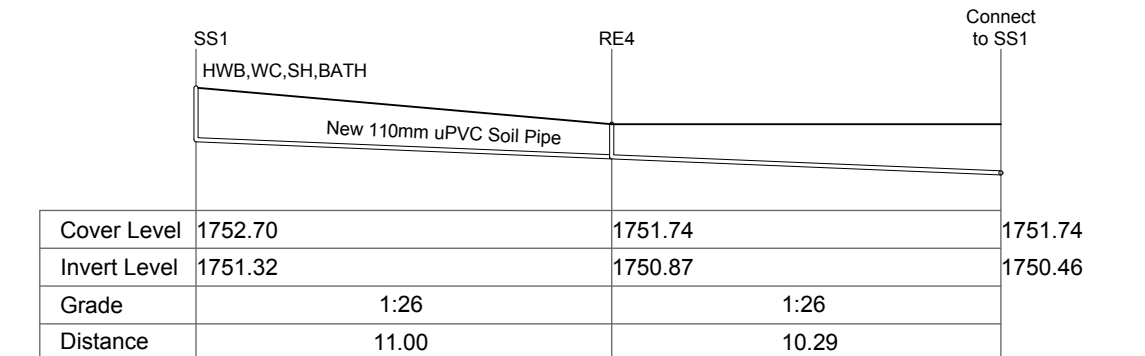
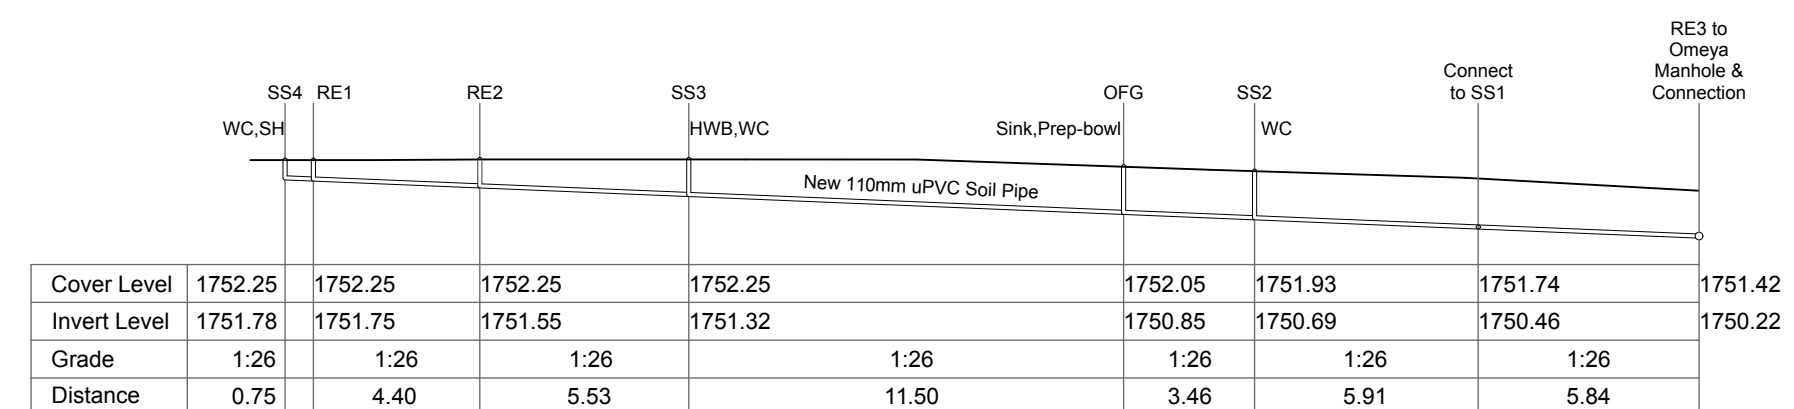
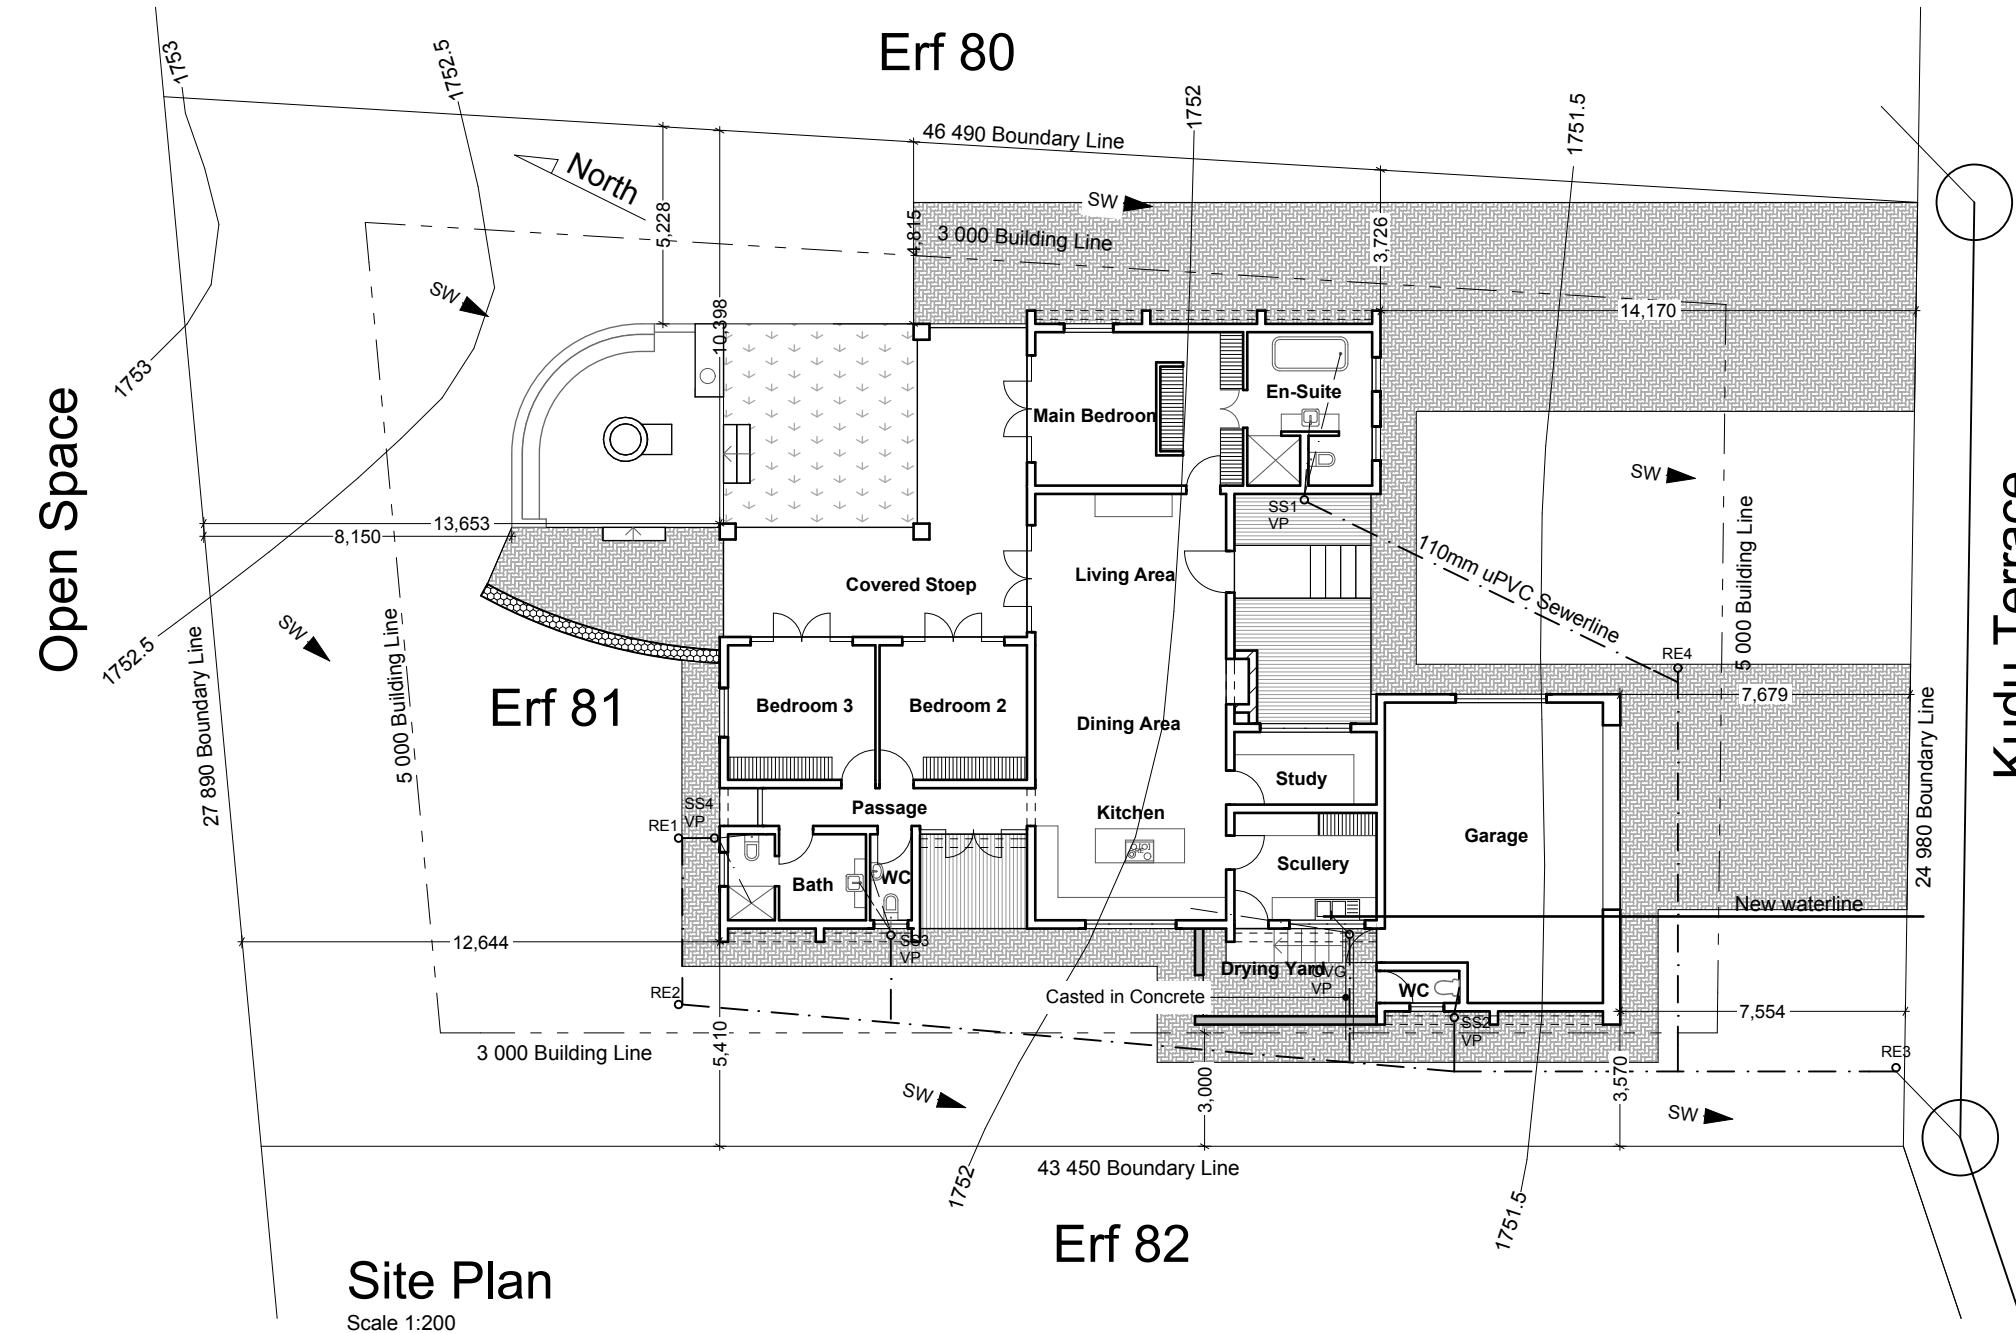
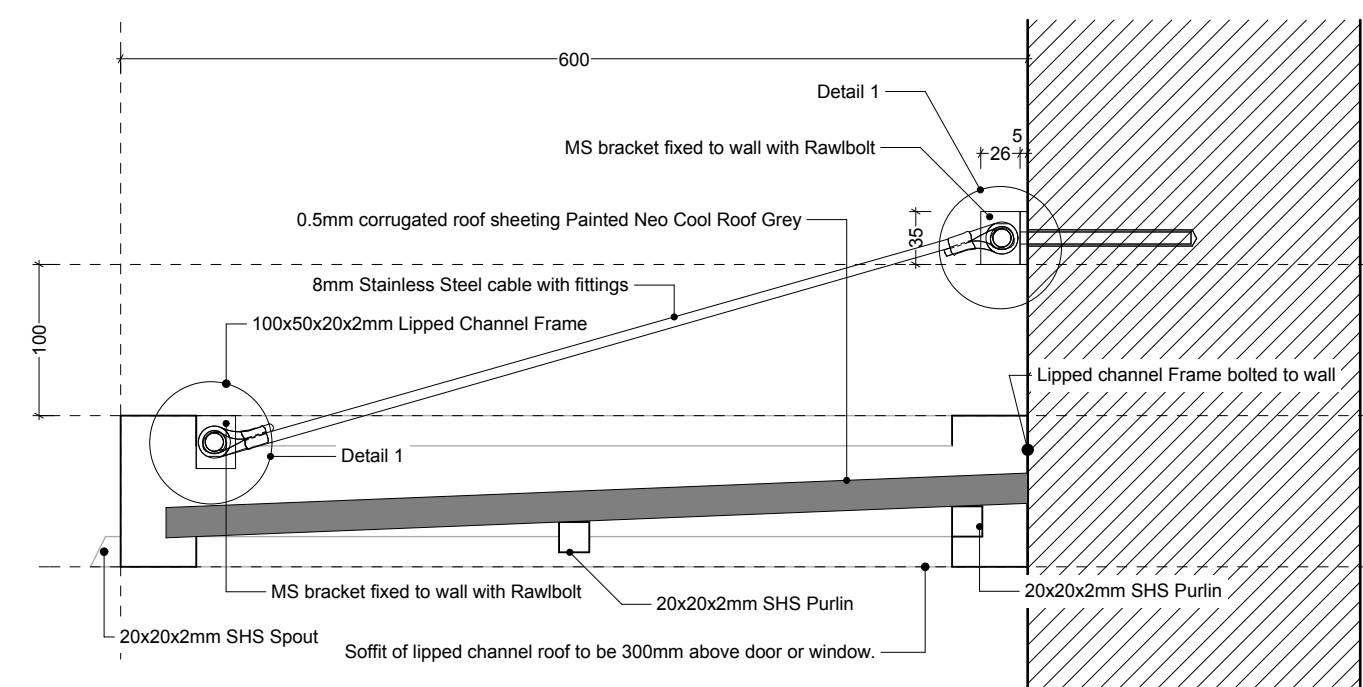
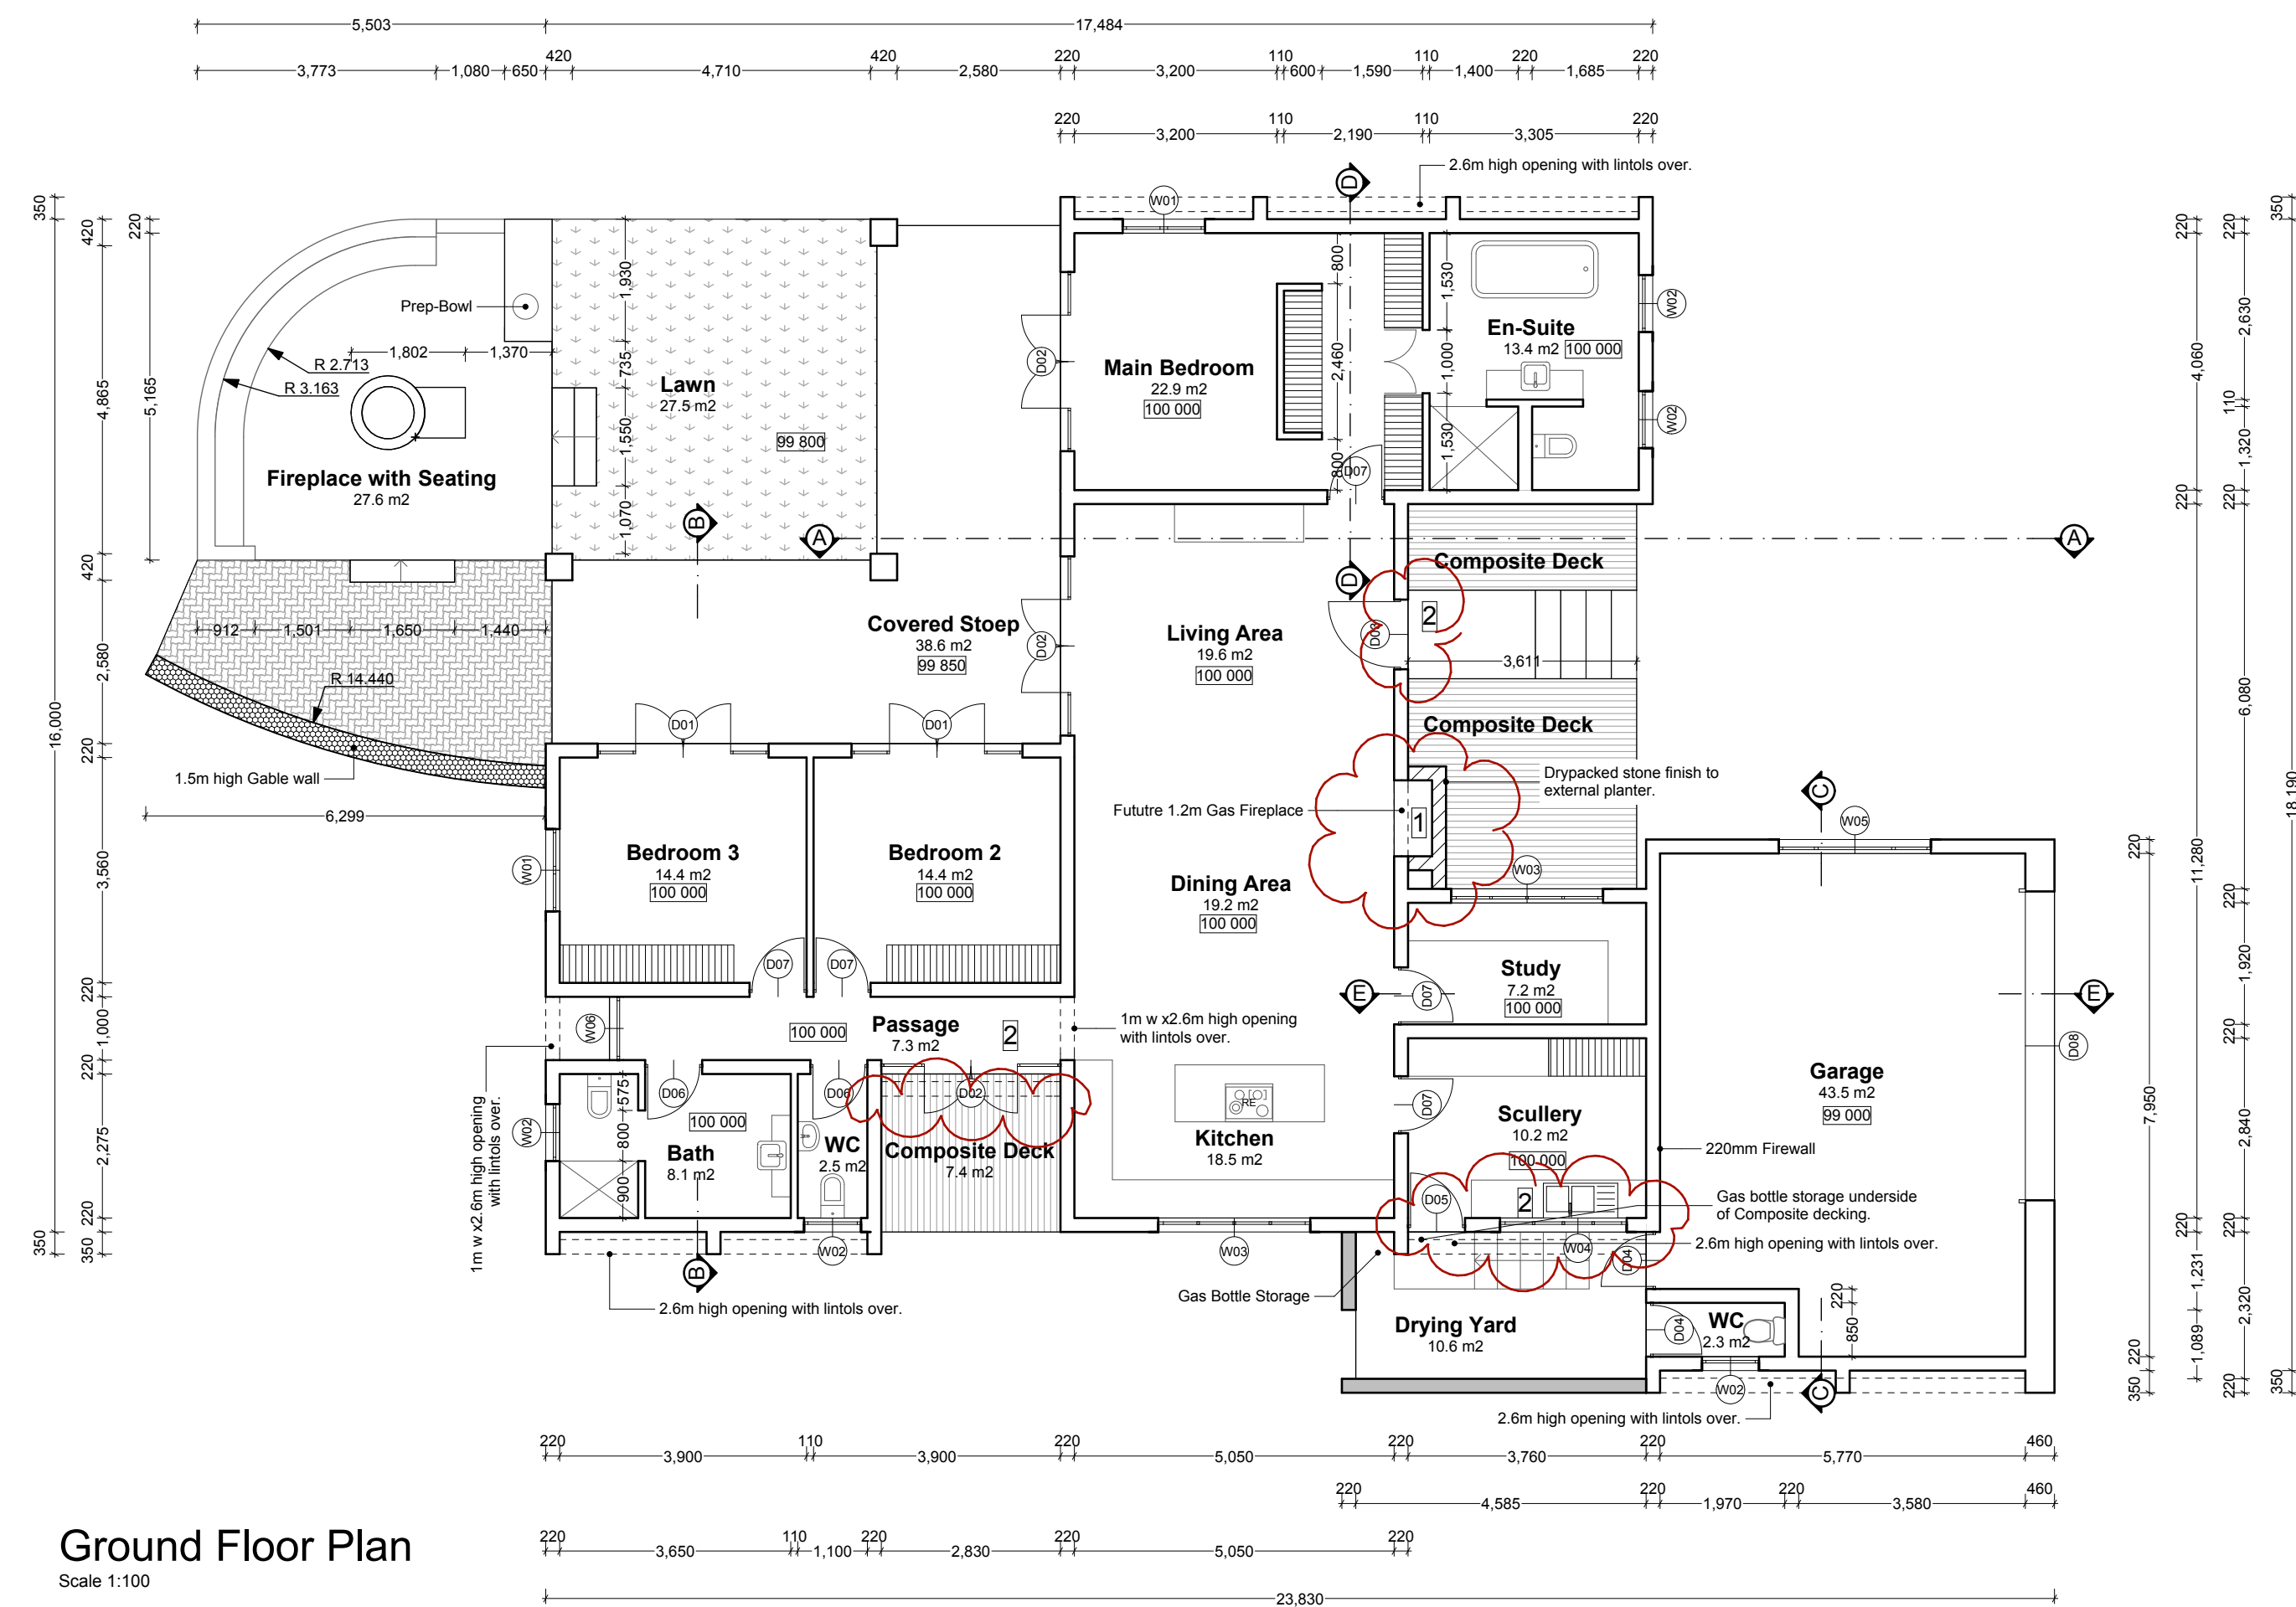


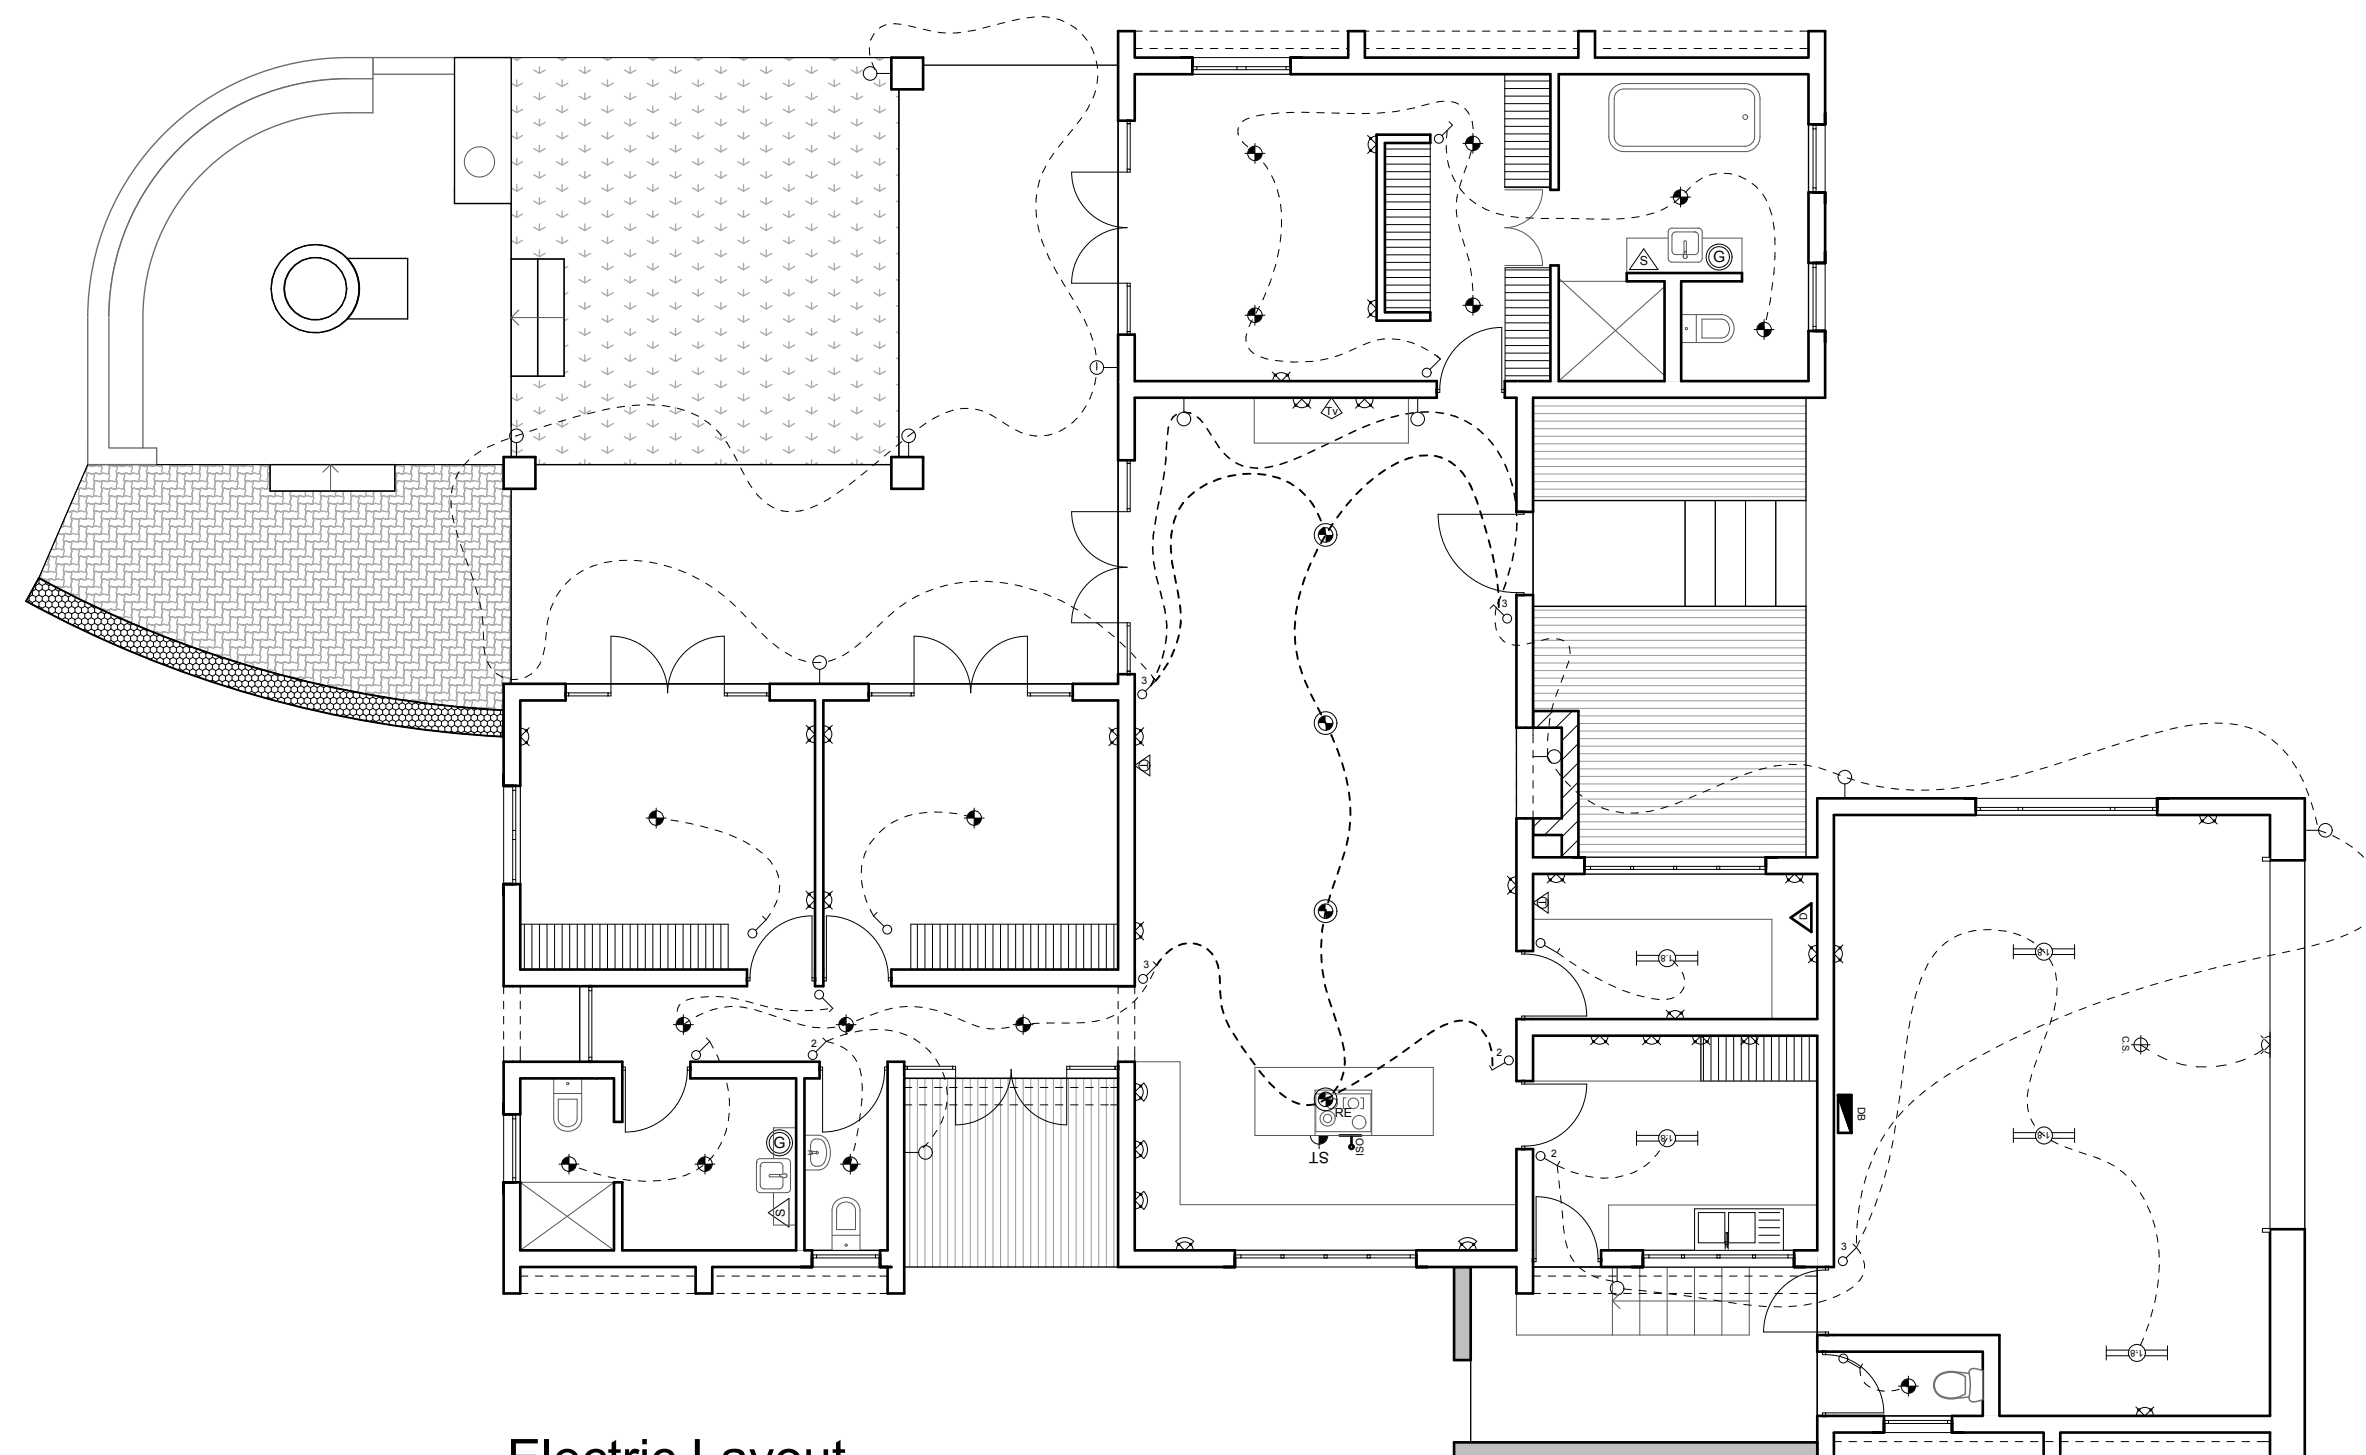

Notes

1. New Gas fireplace to be build in the future.
Composite Decking to be cut according to sizes. Decking steel frame to be re-structured around the fireplace.External wall for new fireplace to be finished with dry packed stone. with 20mm high plastered coping on top and prepared for a planter.
2. Proposal for 3 new Canopies over Doors & Windows for Rain water Protection.See "Proposed canopy detail"

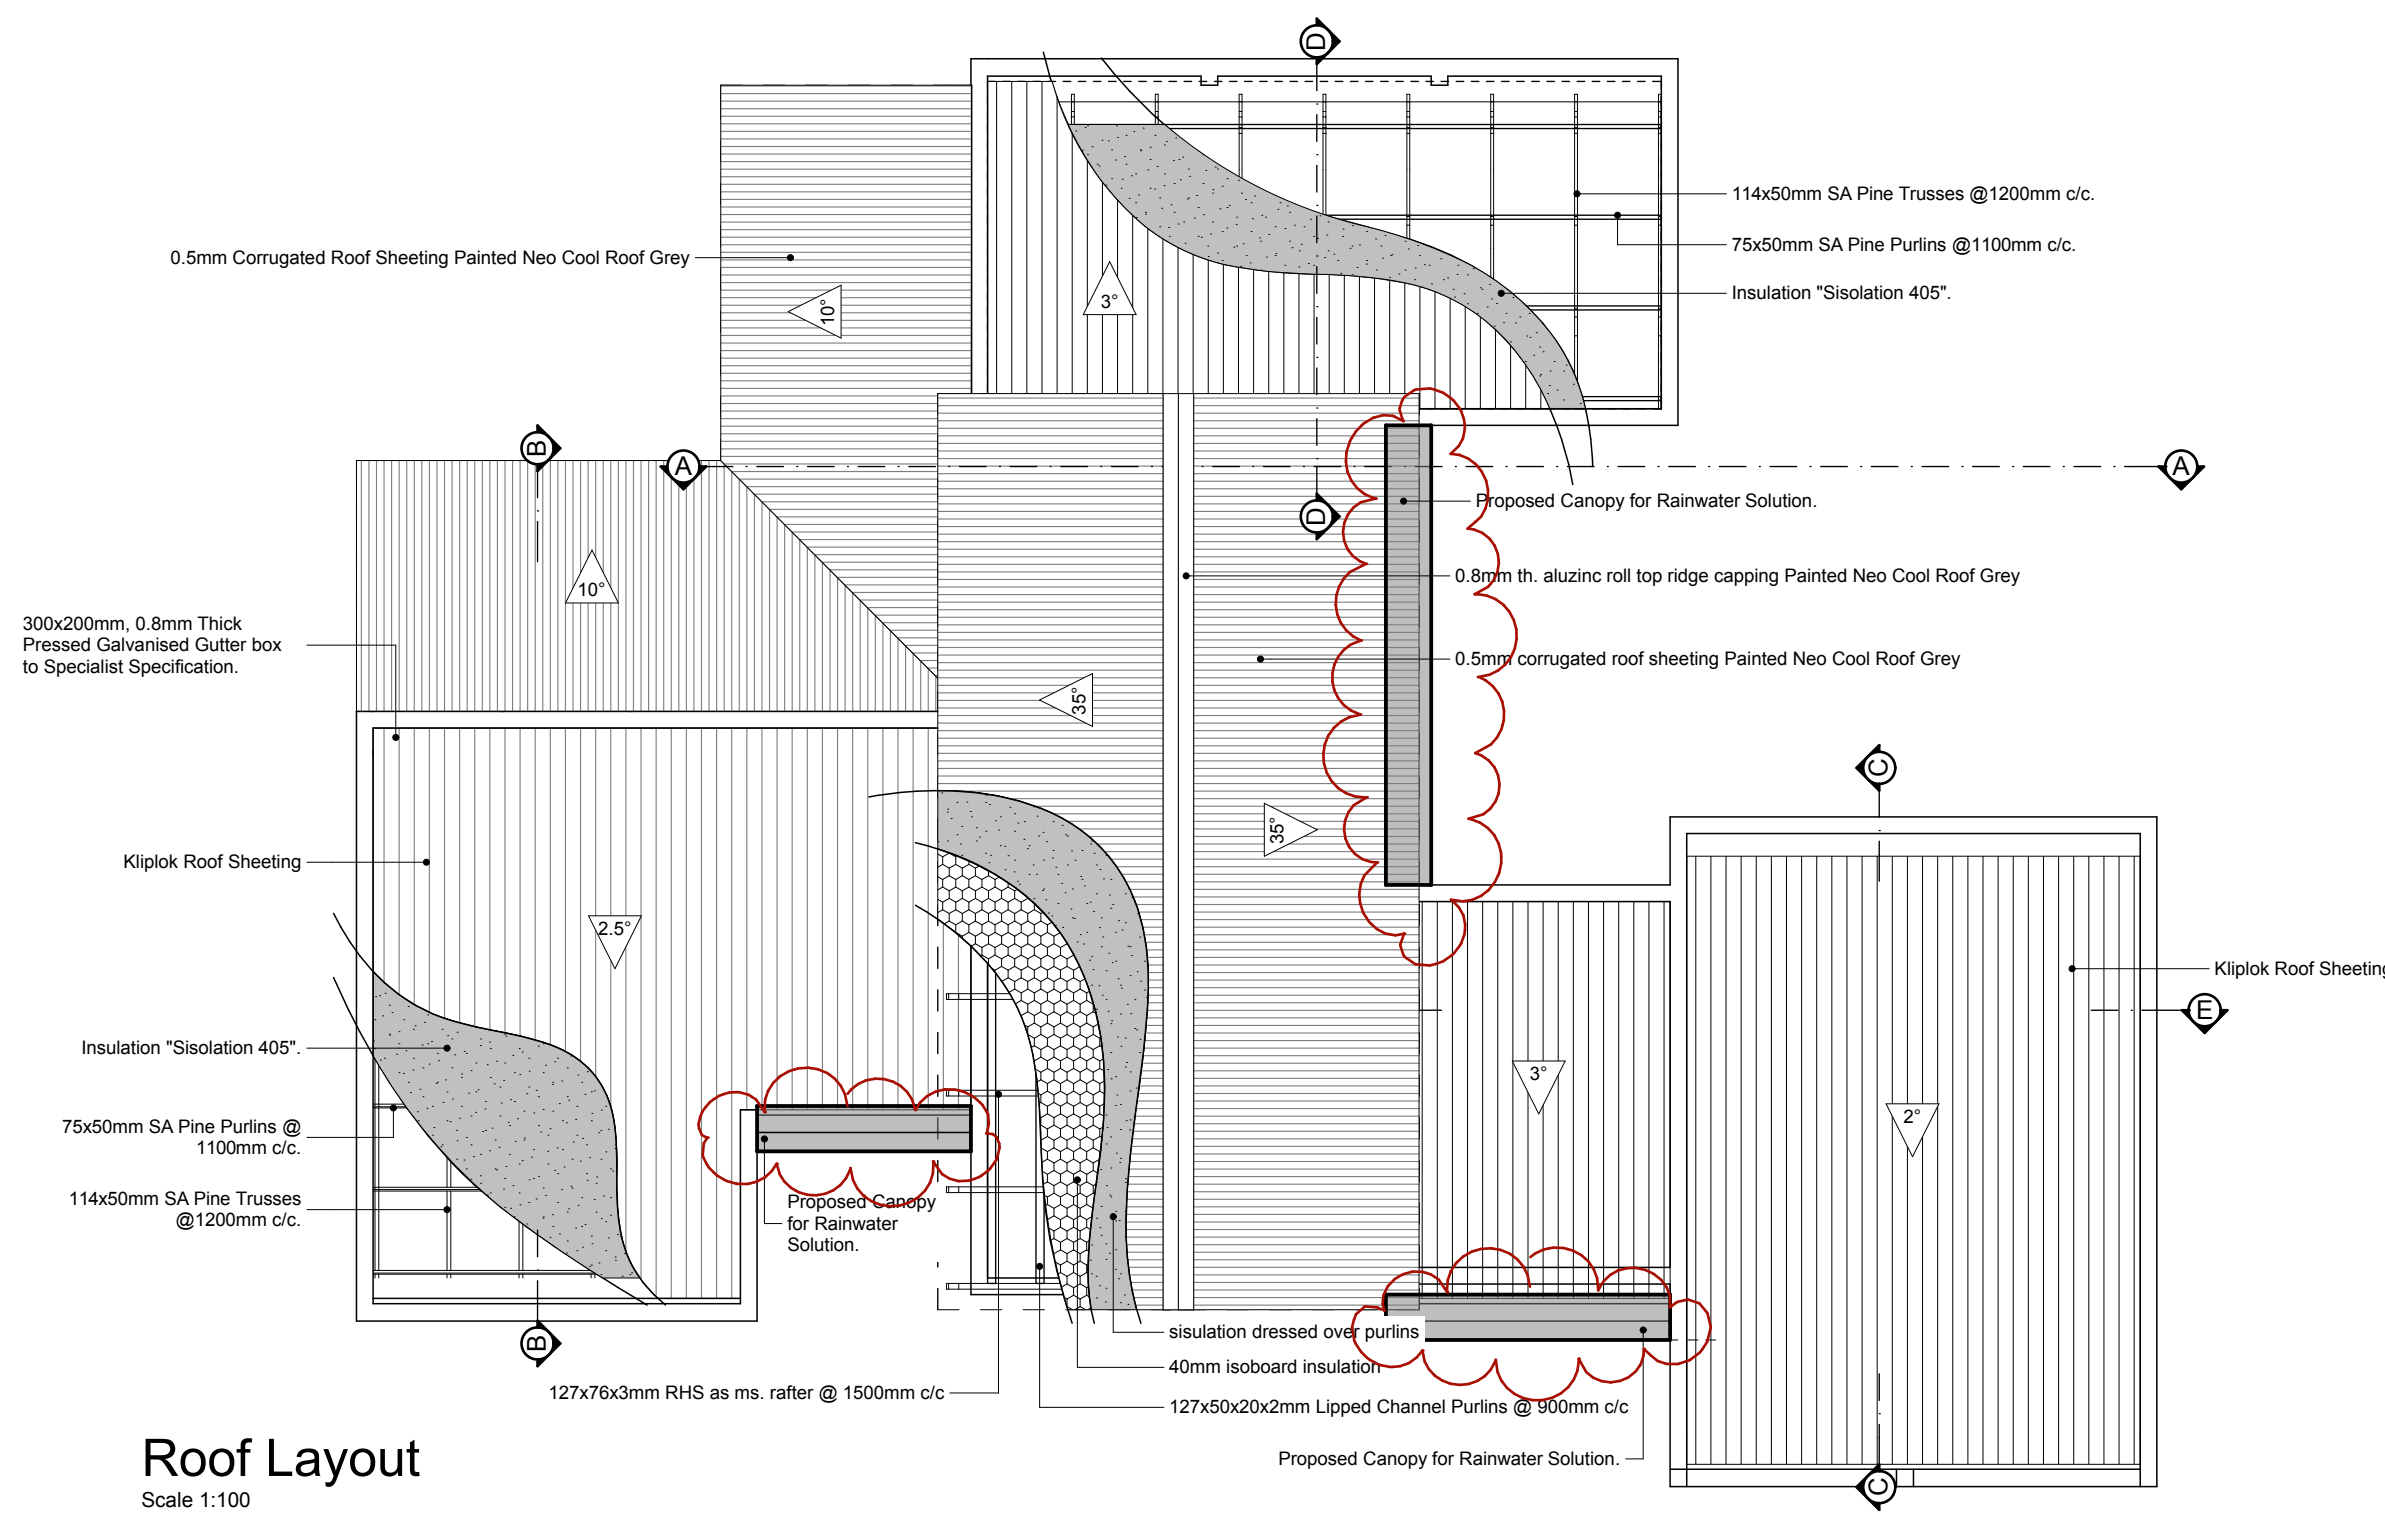

ELECTRICAL LEGEND	
SYMBOL	DESCRIPTION
	FLUORESCENT LIGHT - 2 TUBES
	TELEPHONE CONNECTION
	TELEVISION OUTLET
	DISTRIBUTION BOARD
	150 LTR. HOT WATER CYLINDER IN BULKHEAD
	EXTRACTOR FAN FOR STOVE
	STOVE ISOLATOR
	STOVE POINT
	WALL SOCKET - 400mm FROM F.F.L
	WALL SOCKET - 1000mm FROM F.F.L
	LIGHT SWITCH, 1300mm FROM F.F.L
	TWO WAY LIGHT SWITCH, 1300mm FROM F.F.L
	THREE WAY LIGHT SWITCH, 1300mm FROM F.F.L
	WALL LIGHT - 1800mm FROM F.F.L
	CEILING SOCKET FOR GARAGE DOOR MOTOR
	CEILING FITTED LIGHT
	DATA POINT
	PENDANT LIGHT
	SHAVER POINT

SCHEDULE OF RIGHTS	
DESCRIPTION OF LAND	
LAND AREA	1183 sqm.
BUILDING LINES	3m building line from sides, 5m from street & rear
ZONING	Residential
LAND USE	Dwelling
COVERAGE	23.4%
UNIT	AREA SQM.
Dwelling	182.5 sqm.
Covered Stoep	41.7 sqm.
Garage	52.8 sqm.
TOTAL	277.0 sqm.

[illegible]

ALL DIMENSIONS TO BE CHECKED ON SITE BEFORE ANY WORK
IS PUT IN HAND.
THIS DRAWING TO BE READ IN CONJUNCTION WITH ENGINEER'S
DRAWINGS WHEN APPLICABLE.
DIMENSIONS NOT TO BE SCALED.
ANY DISCREPANCIES AND AMBIGUITIES ON THIS DRAWING TO
BE REPORTED TO THE ARCHITECT.
COPYRIGHT RESERVED.



CONSTRUCTION DOCUMENTATION

Designed:

A TRUTER
ARCHITECTURAL DESIGNS

Cell: 081 127 4581, Work: 061 - 401 750, Fax: 061 - 401 752, 5 Ballot Street
P.O. BOX 11626, WINDHOEK, NAMIBIA E - MAIL: truts@africaonline.com.na



Title:	Siteplan & Ground Floor Plan
Client:	Mrs M.J. Coetzee
Project:	New House on Erf 81, Kudu Terrace, Omeya

Scale:	As Shown	Project No:	81
Date:	November 2011	Drawing No:	81-100-200
Drawn:	Jonathan	Revision:	

Project No:
81

Drawing No:

Revision:

Jonathan